

Republic of the Philippines
PHILIPPINE HEALTH INSURANCE CORPORATION
PhilHealth Regional Office 10

6th Floor Trinidad Building, Yacapin-Corrales Streets, Cagayan de Oro City
 Healthline (088)856-8355 or (08822) 710-473
www.mmalonto@philhealth.gov.ph



JOB ORDER

J.O. No. 087
 Date: December 19, 2012

RIV No. **764-09R**
 Date: **September 19, 2012**

MR. VIRGILIO BERNALES
 President, **POWER LINK AKSA PHILS., INC.**
 Las Piñas City, Metro Manila
 Tel. 02-788-3163/Fax No. 02-872-5649


Sir:

In accordance with the results of the public bidding conducted by **Philhealth Regional Office X** thru its **Bids and Awards Committee** on **December 6, 2012** re: **Materials and Installation of GENERATOR SET 300 kva per Proj. Ref. No. 12-003**, please have the job done as described hereunder:

QTY.	UNIT	DESCRIPTION/SPECIFICATIONS	TOTAL AMOUNT	Date Desired to finish the job
------	------	----------------------------	--------------	--------------------------------

1	lot	Installation of the 300 kva Generator Set with Materials as follows:	P540,000.000	
		288 meters THW Wire #250 sq.mm. 500 MCM		
		40 meters THW Wire #60 sq.mm.		
		10 rolls Rubber tape (3m)		
		10 rolls Electric Plastic Tape (3m)		
		15 pcs. Solderless connector 500 MCM		
		1 roll TW # 14 solid - PD		

(please refer to the attached Single Line Diagram - Annex A)

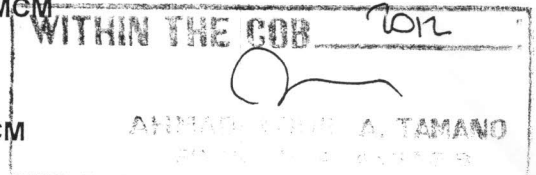

Please deliver the original copy of the Job Order together with your invoice upon completion of this Job for payment.

Very truly yours,

MARIA RHODELLA S. PARE
 Chief, Management Services Division

SPECS/MATERIALS NOTED by:

ROSEL O. M. BAGUNDOL
 TWG-BAC, PRO-X

Funds available in the amount of

P 540,000 chargeable against

Conforme:

FRANCIS A. DACUT
 Comptrollership Unit Head - Designate

APPROVED by:


DATU MASIDING M. ALONTO, JR.
 Regional Vice President, PRO-X

Received Job and held myself bound by the terms, conditions and stipulation of the contract and other applicable rules/law.

successfully emailed
 Bidder/Supplier/Representative
 at plapi@powerlinkaksa.phils.com

Date: 12/28/12

SINGLE LINE DIAGRAM

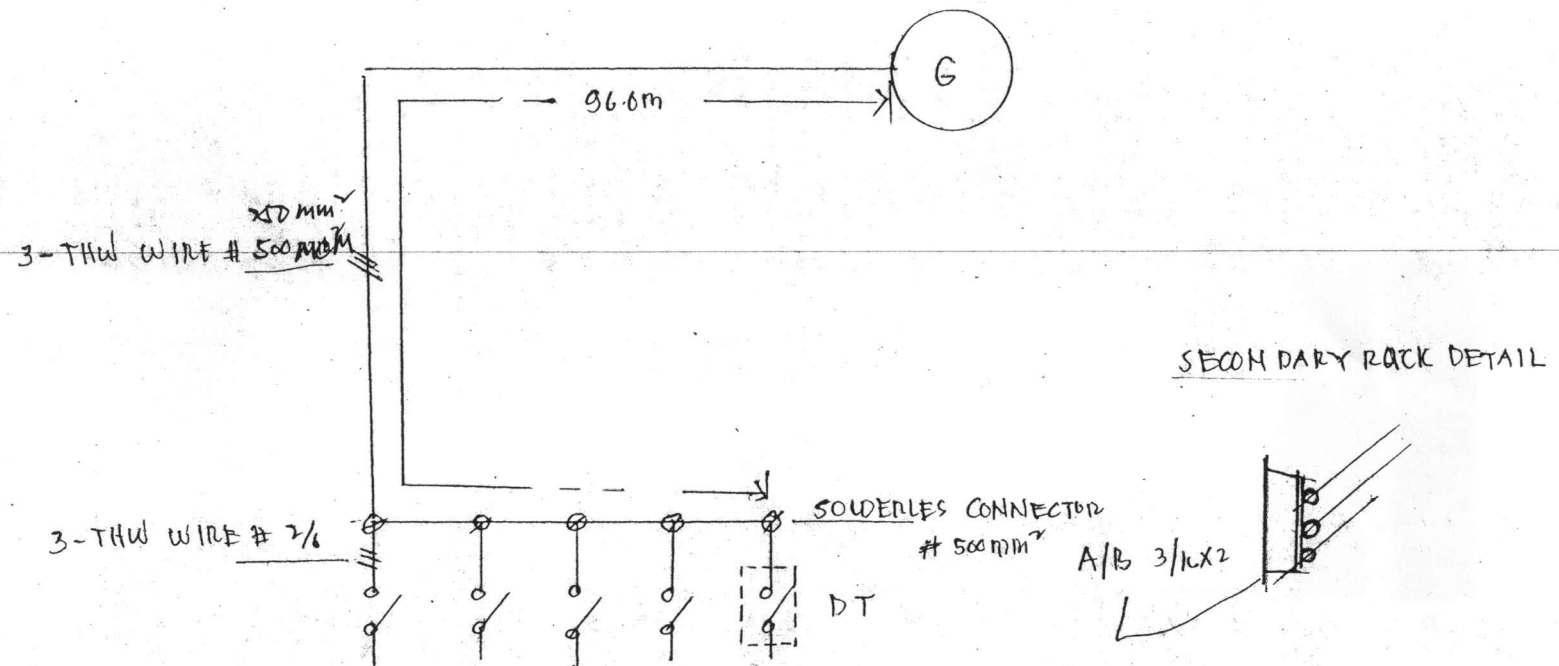

PROJECT: GEN SET ELECTRICAL

LOCATION:

WIRING INSTALLATION

T/BLDG GROUND FLOOR

DRAWN BY:

GAC/m